

LEGENDS

150X50 CMS


Computer point(2X5A+1X15A Socket)

Rack point(2X15A Socket)

1 nos Data outlet

DB

Existing rack

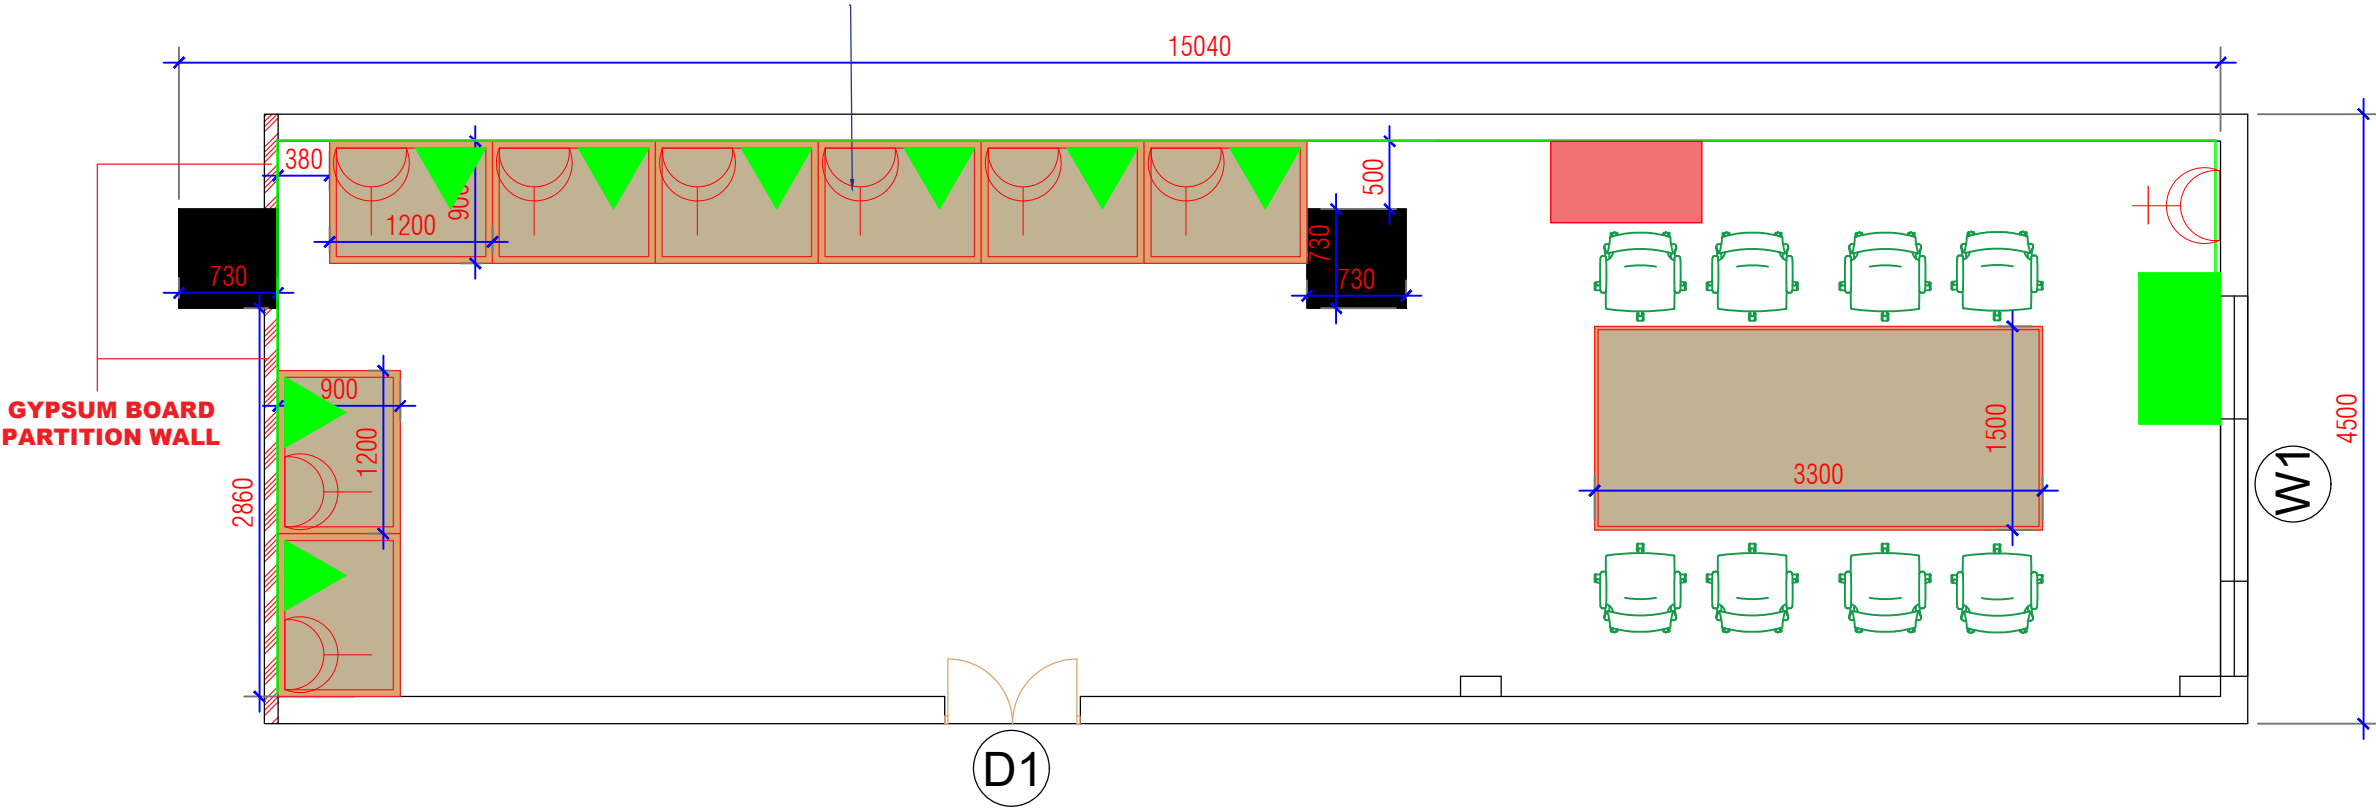

GENERAL NOTES : –

 
1. ALL DIMENSIONS ARE IN MM UNLESS MENTIONED OTHERWISE.
2. ALL DIMENSIONS ARE TO BE READ ONLY AND NOT TO BE MEASURED/ SCALED.

DETAILS OF JOINERY		
NAME	DESCRIPTION	SIZE

ENGINEERING WORKS DIVISION

INDIAN INSTITUTE OF TECHNOLOGY

PALAKKAD

DWG TITLE	PROPOSED 5G LAB ELECTRICAL LAYOUT			 NORTH
	DRAWING			
DRAWING	DRAWN BY			
	CHECKED BY			
	VERIFIED BY			
	DATE		SCALE	
	SHEET SIZE		REV.NO	
	Drawing No.	IITPKD/EWD/5G/EL/01		