

LEGENDS

150X50 CMS

Power circuit


Computer point(2X5A+1X15A Socket)

2 nos Data outlet

Existing DB

Existing rack

Note: Circuit wiring, conduits and CMS to be done in false flooring

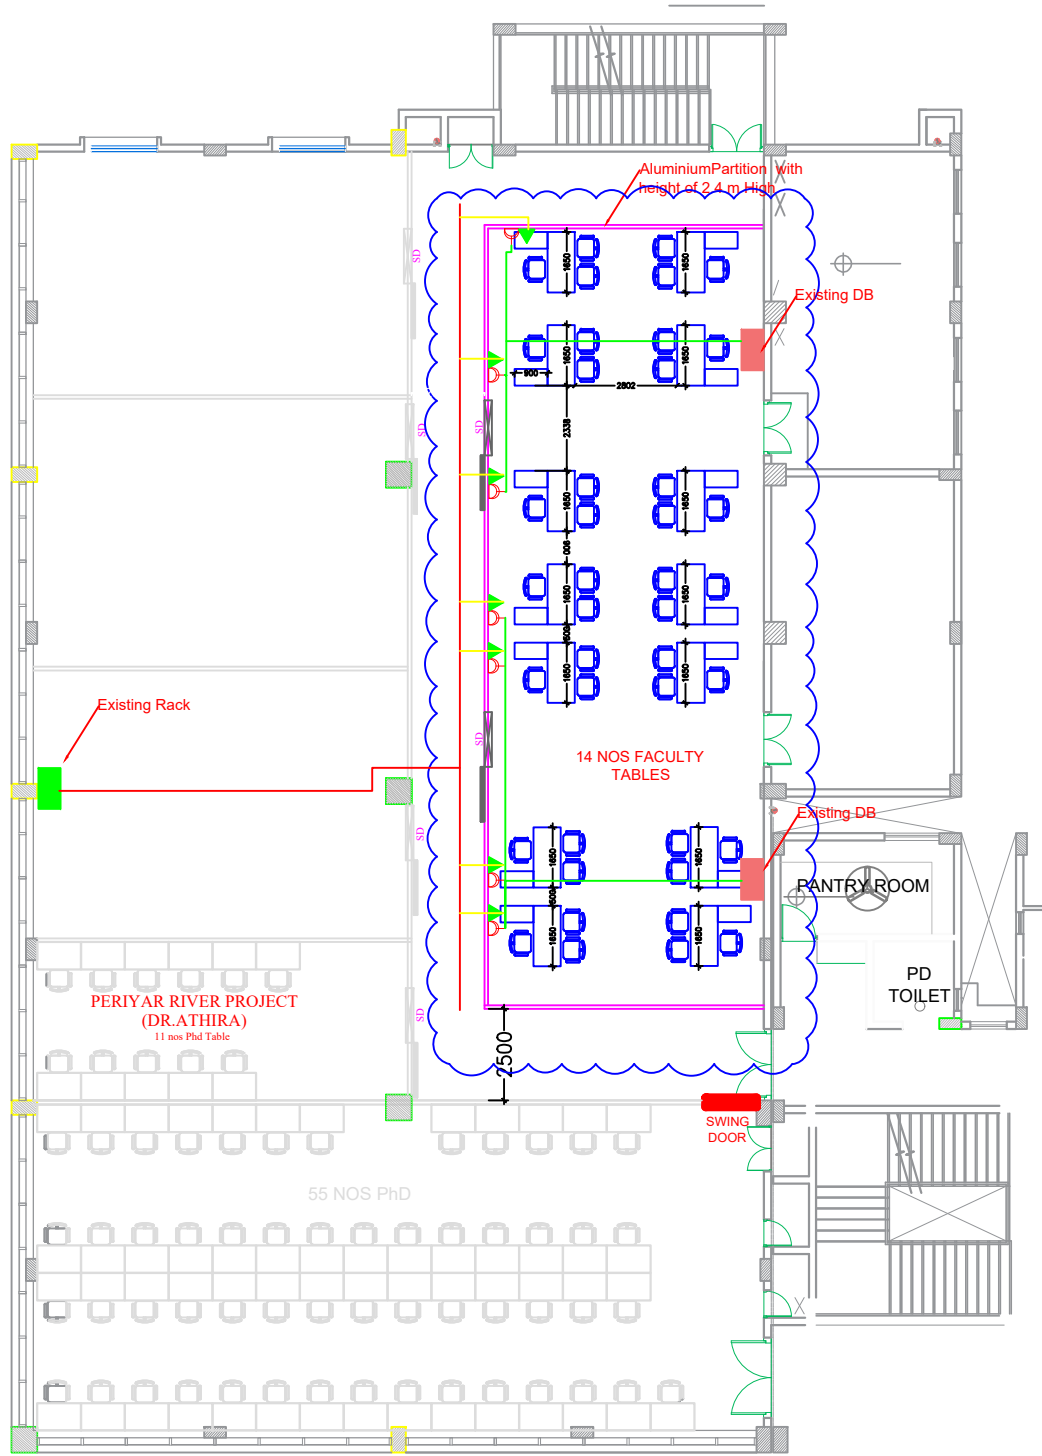

SECOND FLOOR LEFT WING

GENERAL NOTES :-

1. ALL DIMENSIONS ARE IN MM UNLESS MENTIONED OTHERWISE.

2. ALL DIMENSIONS ARE TO BE READ ONLY AND NOT TO BE MEASURED/ SCALED.

DETAILS OF JOINERY

 
NAME	DESCRIPTION	SIZE

REVNO	REVISIONDETAIL	DATE

ENGINEERING WORKS DIVISION
INDIAN INSTITUTE OF TECHNOLOGY
PALAKKAD

DWG TITLE

PROPOSED FACULTY CABIN AT D03
ELECTRICAL LAYOUT


NORTH

DRAWING

DRAWN BY		
CHECKED BY		
VERIFIED BY		
DATE		SCALE
SHEET SIZE		REV.NO

Drawing No.

IITPKD/EWD/D03/EL/01